


**PLAN - SCOOTER PARKING SHED FOR 50 SCOOTERS (04 BLOCKS)**  
SCALE: 1:100

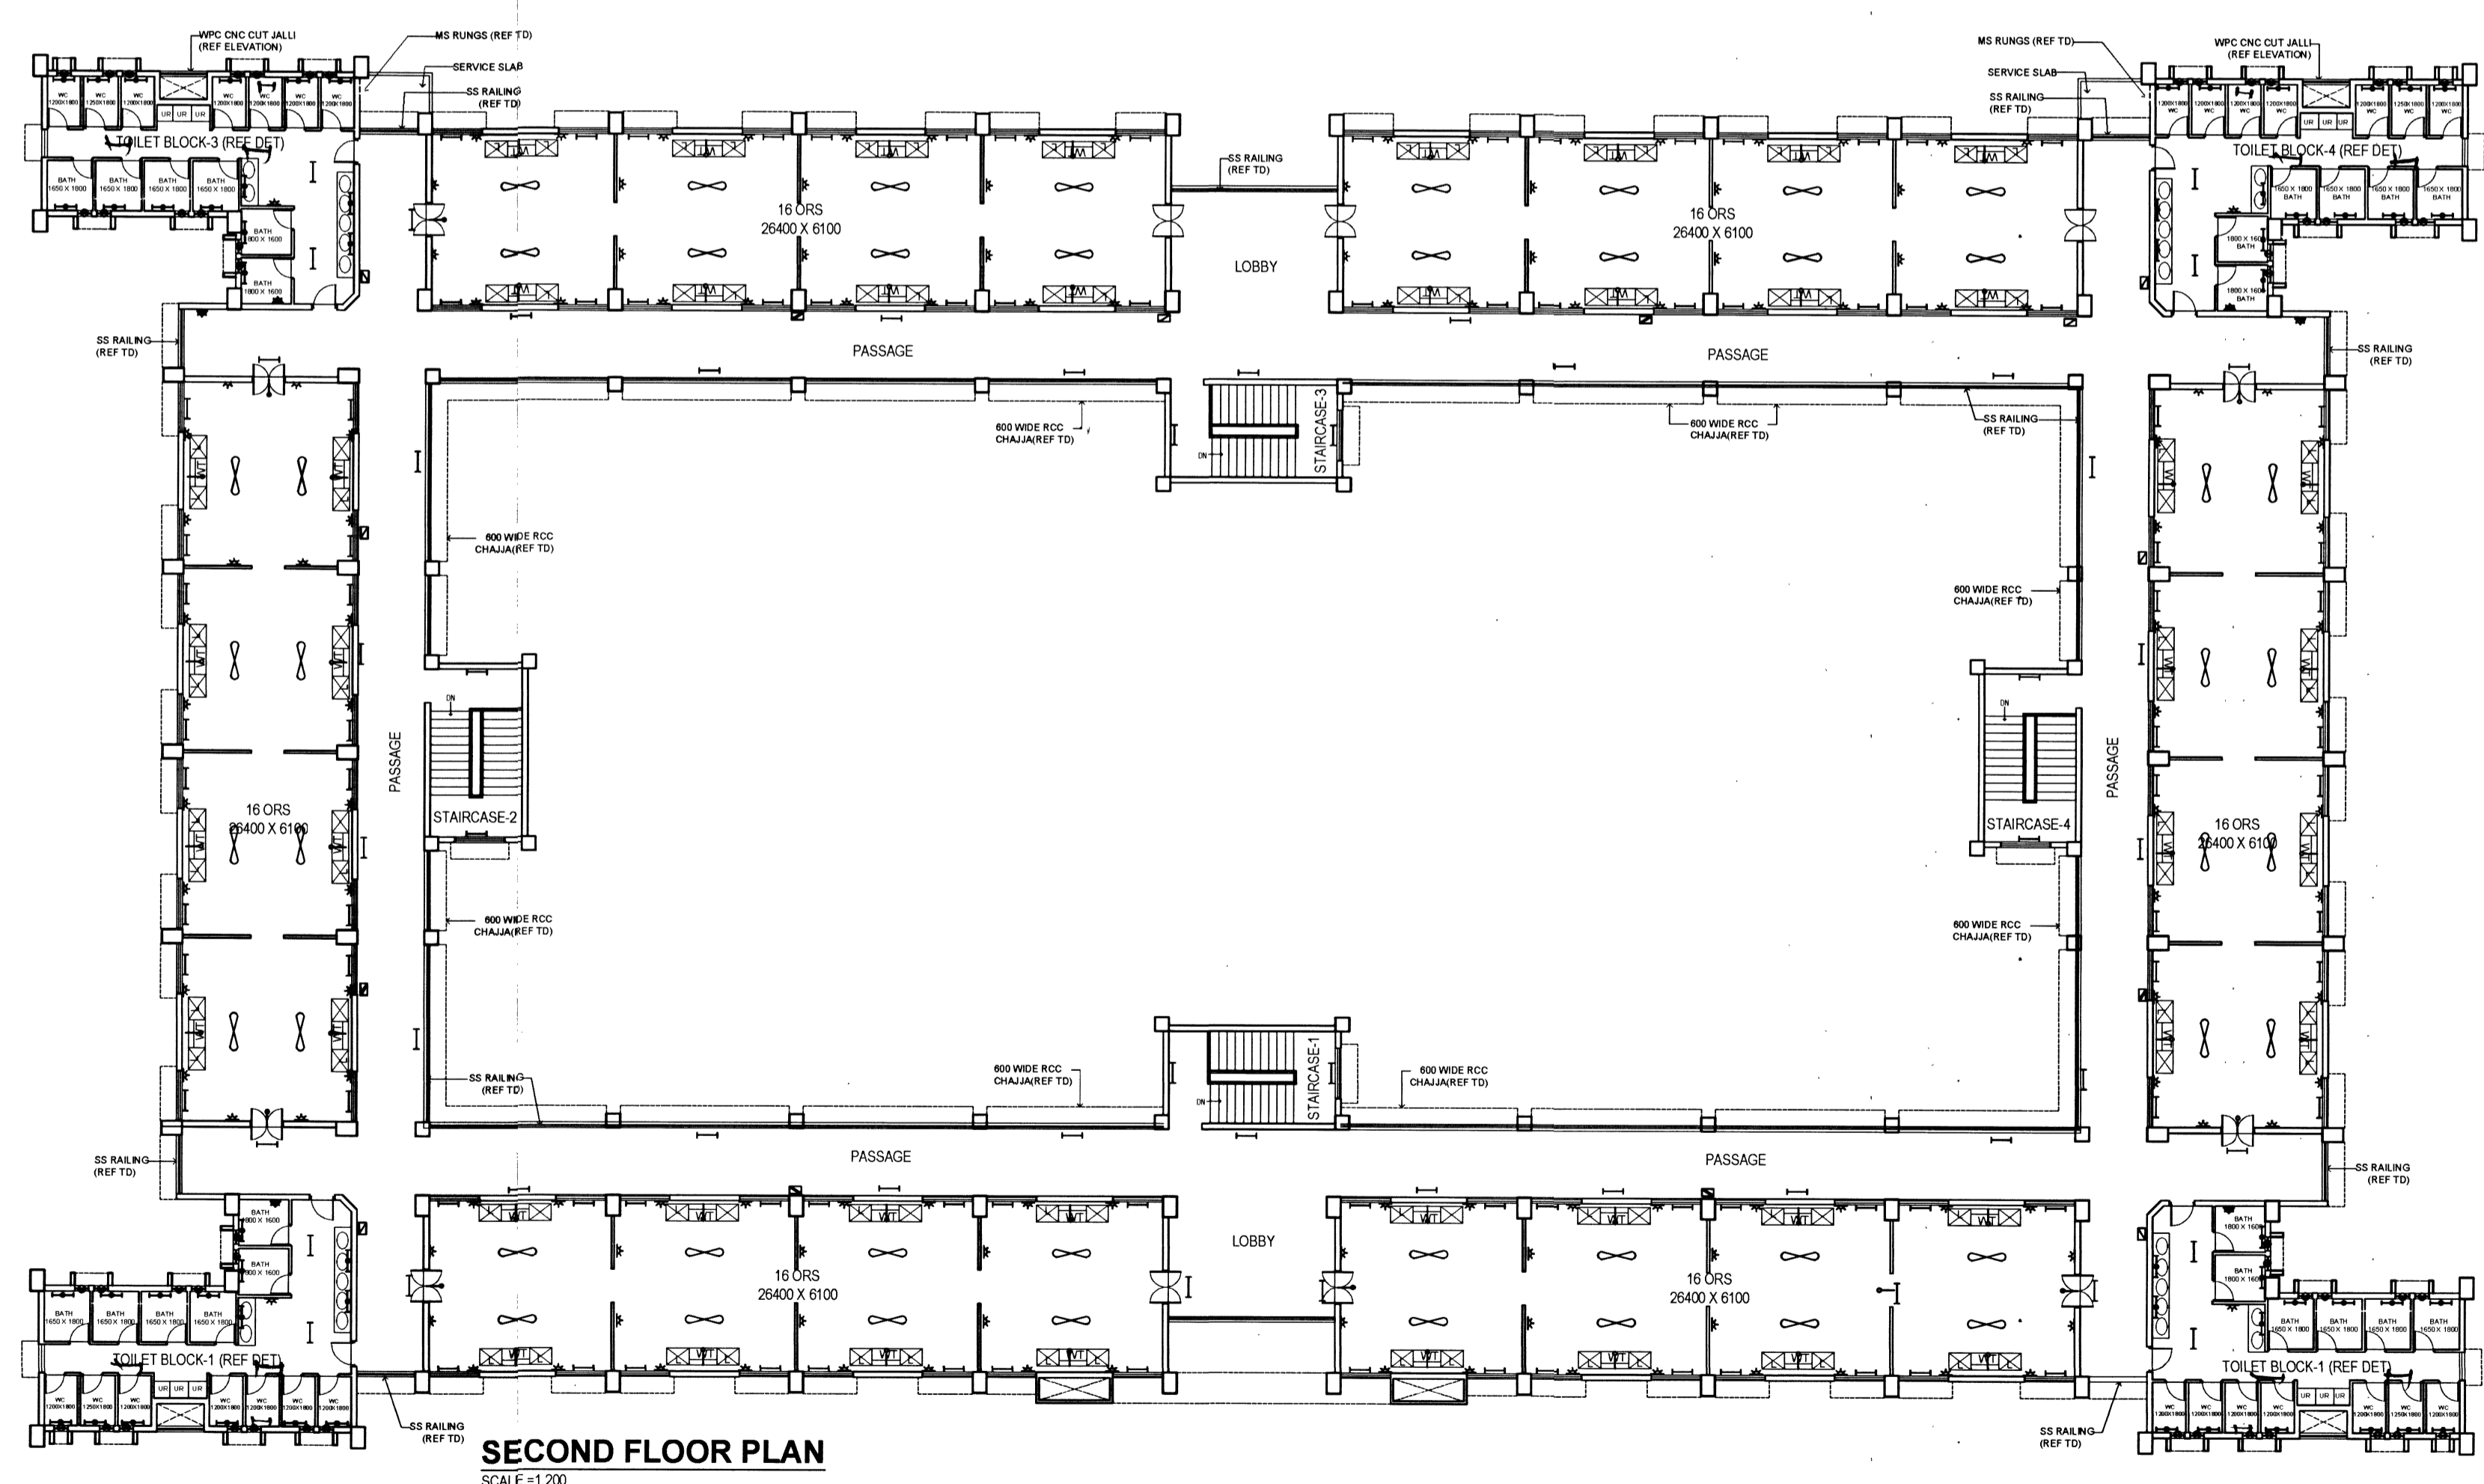

**SECOND FLOOR PLAN**  
SCALE: 1:200


LEGEND		
SL. NO.	NAME	SYMBOL
1.	1 X 20 W LED TUBELIGHT	
2.	LED FITTING 1X10W	
3.	LED DOWNLIGHT 15 W	
4.	CEILING FAN 1400 mm SWEEP	
5.	EXHAUST FAN 300 mm	
6.	DB VTPN 8 WAY	
7.	DB VTPN 4 WAY	
8.	DB SPN 8 WAY	
9.	DB SPN 12 WAY	
10.	LED 2' X 2' PANEL LIGHT 36W	
11.	LAMP HOLDER	
12.	BUILDING SECURITY LIGHT	
13.	BULK HEAD FITTING 10W	
14.	5 AMP SOCKET	
15.	15 AMP SOCKET	
16.	15 AMP SOCKET WITH MCB	

**NOTES**

No.	DESCRIPTION	Date	SIGN
	Revision		
Project Name			
<b>PROVN OF SINGLEMAN ACCOMMODATION FOR 250 X AGNIVEERS IN DRIVING &amp; MAINTENANCE REGIMENT AT ACC &amp; S AHMEDNAGAR.</b>			
SINGLE LIVING ACCN FOR 250 AGNIVEER & SCOOTER PARKING SHED FOR 50 SCOOTERS (04 BLOCKS)			
INTERNAL ELECTRIFICATION PLAN GF OF SCOOTER SHED & SECOND FLOOR 250 AGNIVEER			
DATE: 13-04-2026	<b>CHIEF ENGINEER</b> <b>PUNE ZONE</b>	SHT NO	
DRN: <i>C. S. Desai</i>		3 / 3	
SCALE: 1:200			
<b>DRG NO: -CEPZ/2026/ANR/EM/04</b>			
<i>Arjani</i> AAD (ARCH)	<i>Desai</i> AAD (U)	<i>[Signature]</i> DIRECTOR (U) FOR CHIEF ENGR	

D:\02 WORKING DRG\2026\CWE DEVLALI\WORKING DRG\FINAL 250 AGNIVEER\FINAL REVISED 250 AGNIVEERS\EM DRG



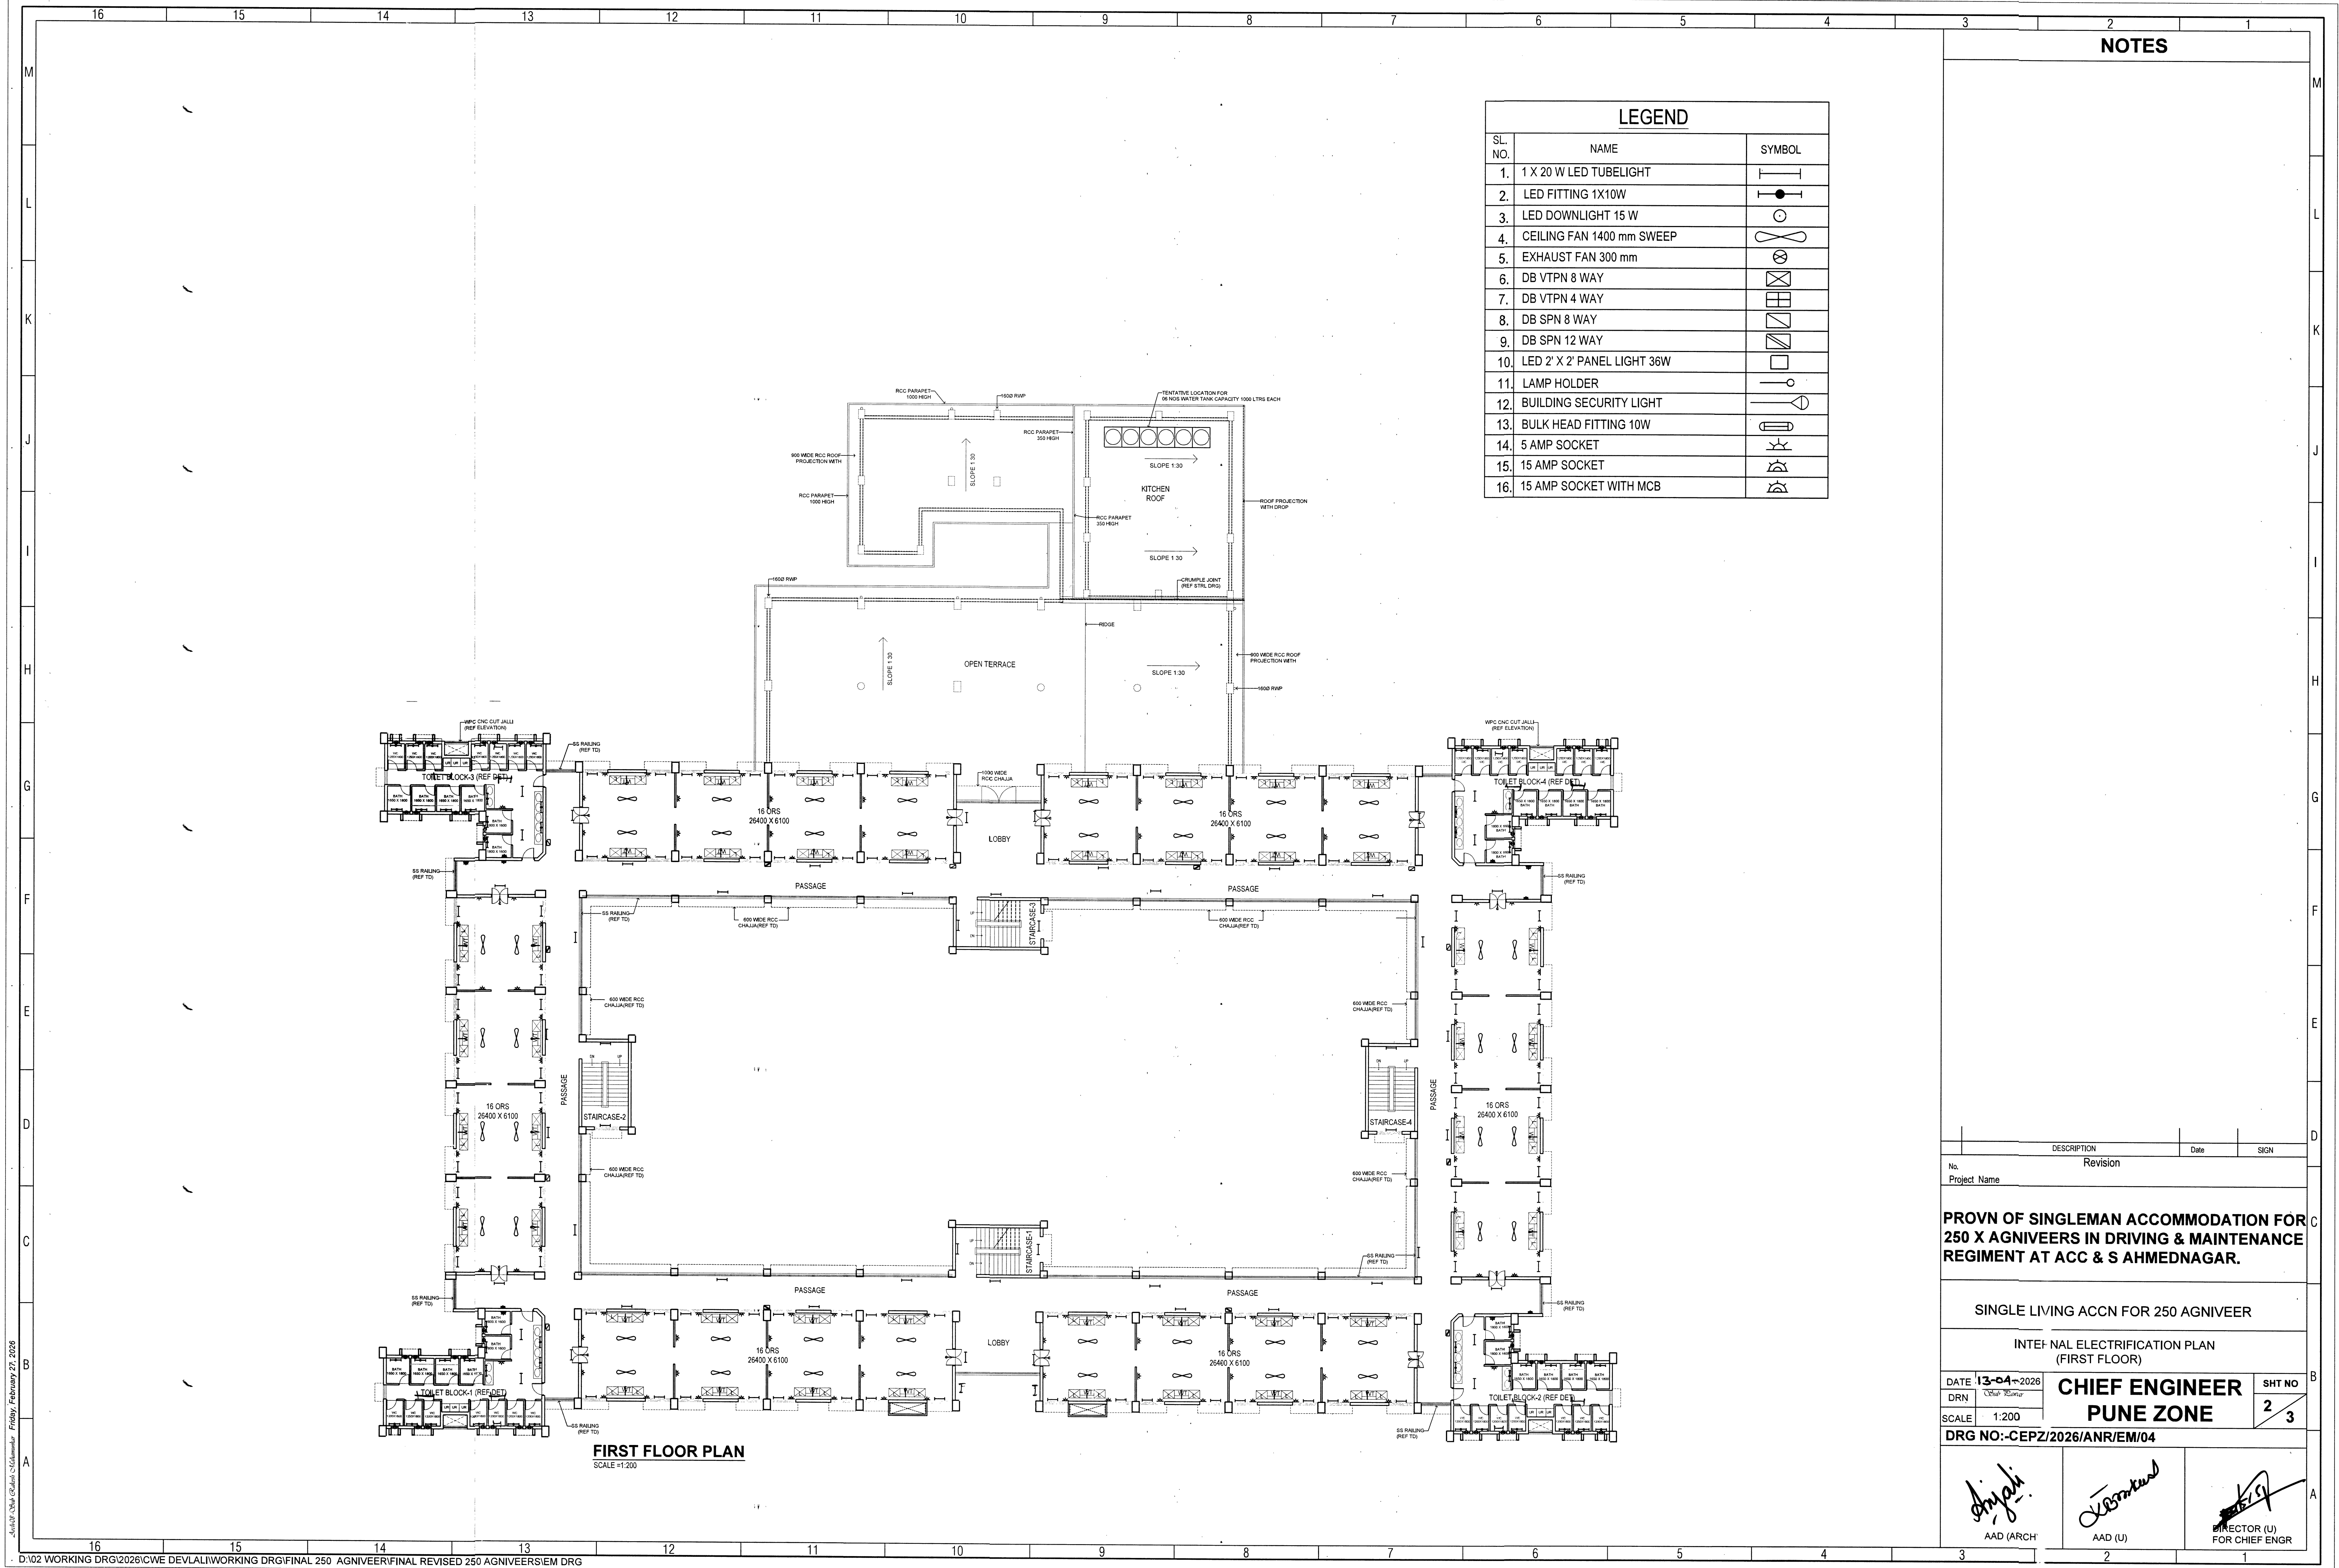

LEGEND		
SL. NO.	NAME	SYMBOL
1.	1 X 20 W LED TUBELIGHT	[Symbol]
2.	LED FITTING 1X10W	[Symbol]
3.	LED DOWNLIGHT 15 W	[Symbol]
4.	CEILING FAN 1400 mm SWEEP	[Symbol]
5.	EXHAUST FAN 300 mm	[Symbol]
6.	DB VTPN 8 WAY	[Symbol]
7.	DB VTPN 4 WAY	[Symbol]
8.	DB SPN 8 WAY	[Symbol]
9.	DB SPN 12 WAY	[Symbol]
10.	LED 2' X 2' PANEL LIGHT 36W	[Symbol]
11.	LAMP HOLDER	[Symbol]
12.	BUILDING SECURITY LIGHT	[Symbol]
13.	BULK HEAD FITTING 10W	[Symbol]
14.	5 AMP SOCKET	[Symbol]
15.	15 AMP SOCKET	[Symbol]
16.	15 AMP SOCKET WITH MCB	[Symbol]

**NOTES**

No.	DESCRIPTION	Date	SIGN
Revision			
Project Name			
<b>PROVN OF SINGLEMAN ACCOMMODATION FOR 250 X AGNIVEERS IN DRIVING &amp; MAINTENANCE REGIMENT AT ACC &amp; S AHMEDNAGAR.</b>			
SINGLE LIVING ACCN FOR 250 AGNIVEER			
INTERNAL ELECTRIFICATION PLAN (FIRST FLOOR)			
DATE: 13-04-2026	<b>CHIEF ENGINEER</b>		SHT NO
DRN: [Signature]	<b>PUNE ZONE</b>		2
SCALE: 1:200	DRG NO:-CEPZ/2026/ANR/EM/04		3
[Signature]	[Signature]	[Signature]	
AAD (ARCH)	AAD (U)	DIRECTOR (U) FOR CHIEF ENGR	

16  
15  
14  
13  
12  
11  
10  
9  
8  
7  
6  
5  
4  
3  
2  
1  
M  
L  
K  
J  
I  
H  
G  
F  
E  
D  
C  
B  
A