


SKETCH 'P'

SERVICES LEGEND - ELECTRIC SUPPLY	
PROPOSED BLDG	[Symbol]
EXISTING 4 POLE STRUCTURE	[Symbol]
PROPOSED 160 KVA TRANSFORMER	[Symbol]
PROPOSED LT PANEL	[Symbol]
PROPOSED HT CABLE 95 SQ MM 3 CORE	— 95-3C —
PROPOSED LT CABLE 95 SQ MM 3.5 CORE	— 95-3.5 —
PROPOSED LT CABLE 70 SQ MM 3.5 CORE	— 70 —
PROPOSED LT CABLE 35 SQ MM 3.5 CORE	— 35-3.5 —
PROPOSED LT POLE	●
PROPOSED LT CABLE 10 X 4 CORE	— 10X4 —
PROPOSED LT POLE 10 X 2 CORE	— 10X2 —

SERVICES LEGEND - WATER SUPPLY	
PROPOSED BLDG	[Symbol]
EXISTING OHT	[Symbol]
EXISTING VALVE CHAMBER WITH 200 MM SV	[Symbol]
PROPOSED VALVE CHAMBER	[Symbol]
PROPOSED GI PIPE 80 MM	— 80 GI — 80 GI —
PROPOSED GI PIPE 50 MM	— 50 GI — 50 GI —

No.	DESCRIPTION	Date	SIGN
Project Name			
PROVN OF SINHLE MAN ACCOMMODATION FOR 250 X AGNIVEERS IN DRIVING & MAINTENANCE REGIMEN AT ACC & S AHMEDNAGAR.			
SITE PLAN SHOWING EXTERNAL E&M SERVICES			
DATE	13-04-2026	CHIEF ENGINEER	
DRN	SUB MU PAWAR	PUNE ZONE	
SCALE	1:400	SHT NO 2/2	
DRG NO:-CEPZ/2026/ANR/SP/04			
[Signature]		[Signature]	
AAD (ARCH)		AAD (U)	
		FOR CHIEF ENGINEER PUNE ZONE	

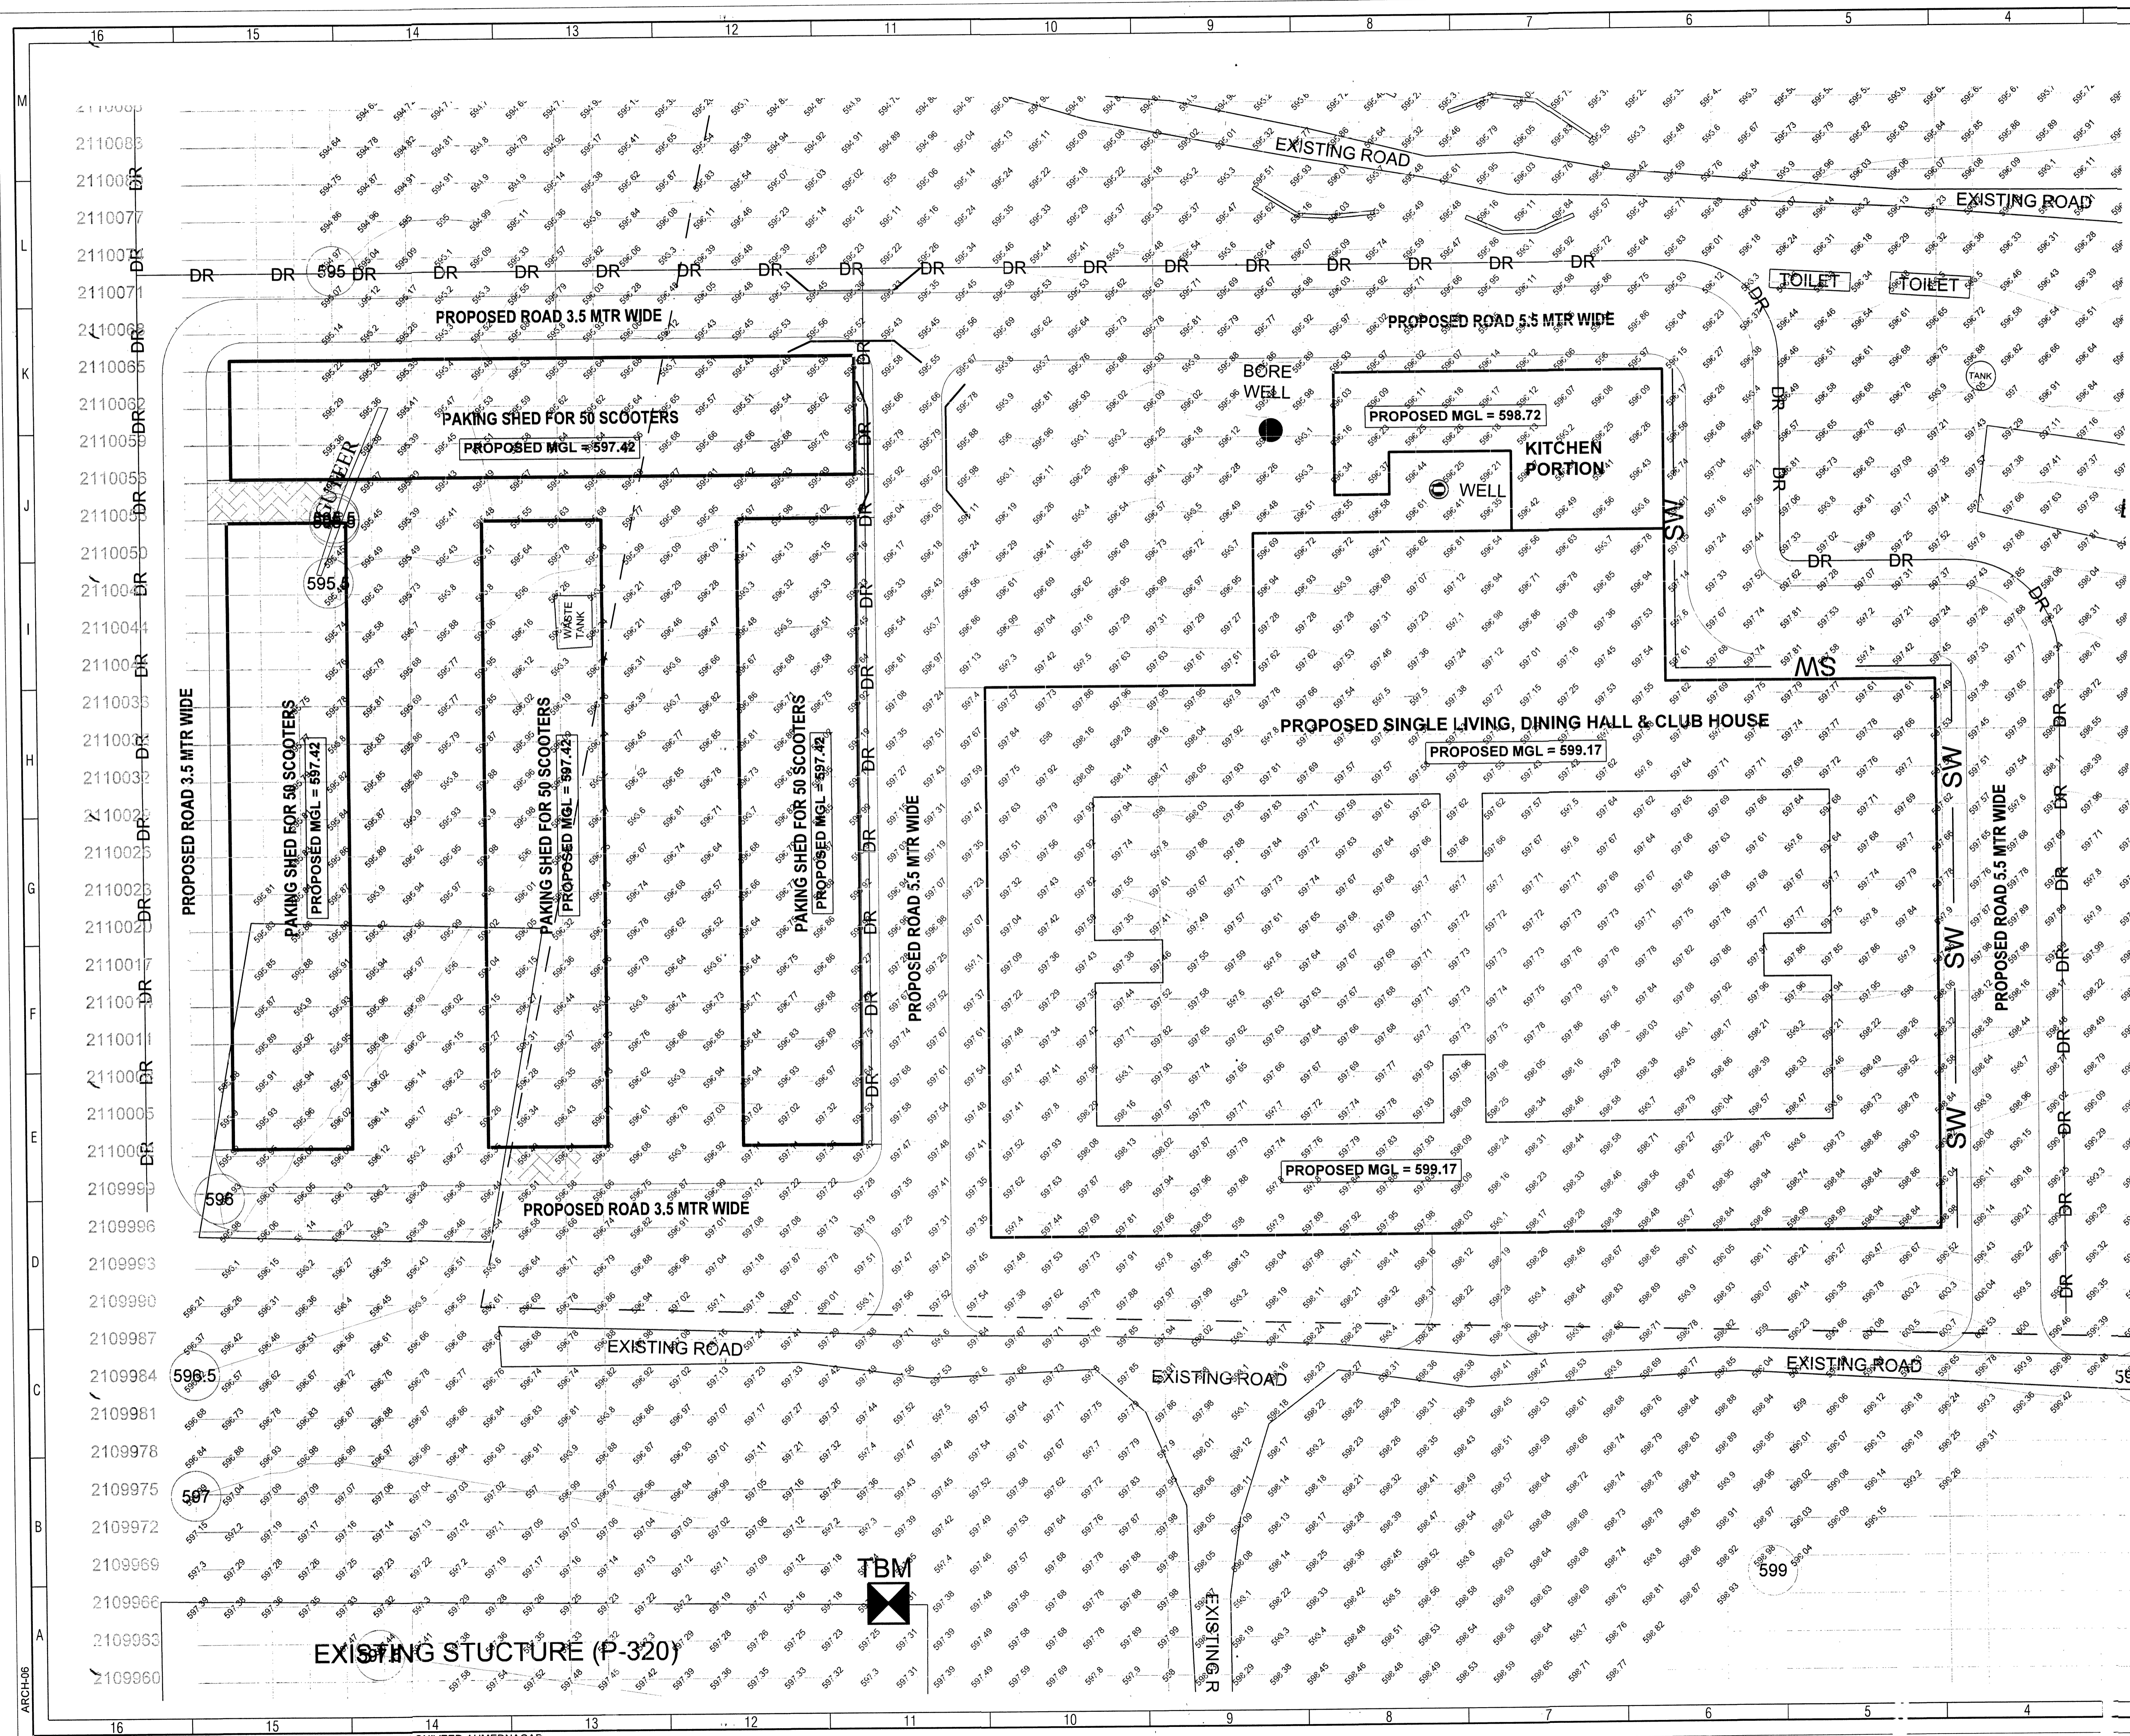

☒ TBM : 600 (AT P-320)

SER	BUILDING LOCATION	PROPOSED MGL
1	SINGLE LIVING, DINING HALL & CLUB HOUSE	599.17
2	KITCHEN PORTION	598.72
3	SCOOTER PARKING AREA	597.42

No.	Description	Date	Sign
	Revision		

Project Name
PROVN OF SINGLE MAN ACCOMMODATION FOR 250 X AGNIVEERS IN DRIVING & MAINTENANCE REGIMENT AT ACC & S AHMEDNAGAR.

CONTOUR MAP WITH PROPOSED MGL


DATE	13APR 2026	CHIEF ENGINEER	SHT NO
DRN	13/04/2026		
SCALE	1:250	1	

DRG NO:-CEPZ/2026/ANR/CM/04


AAD (ARCH)

 AAD (PLG)

 DR (PLG)
 FOR CHIEF ENGINEER
 PUNE ZONE

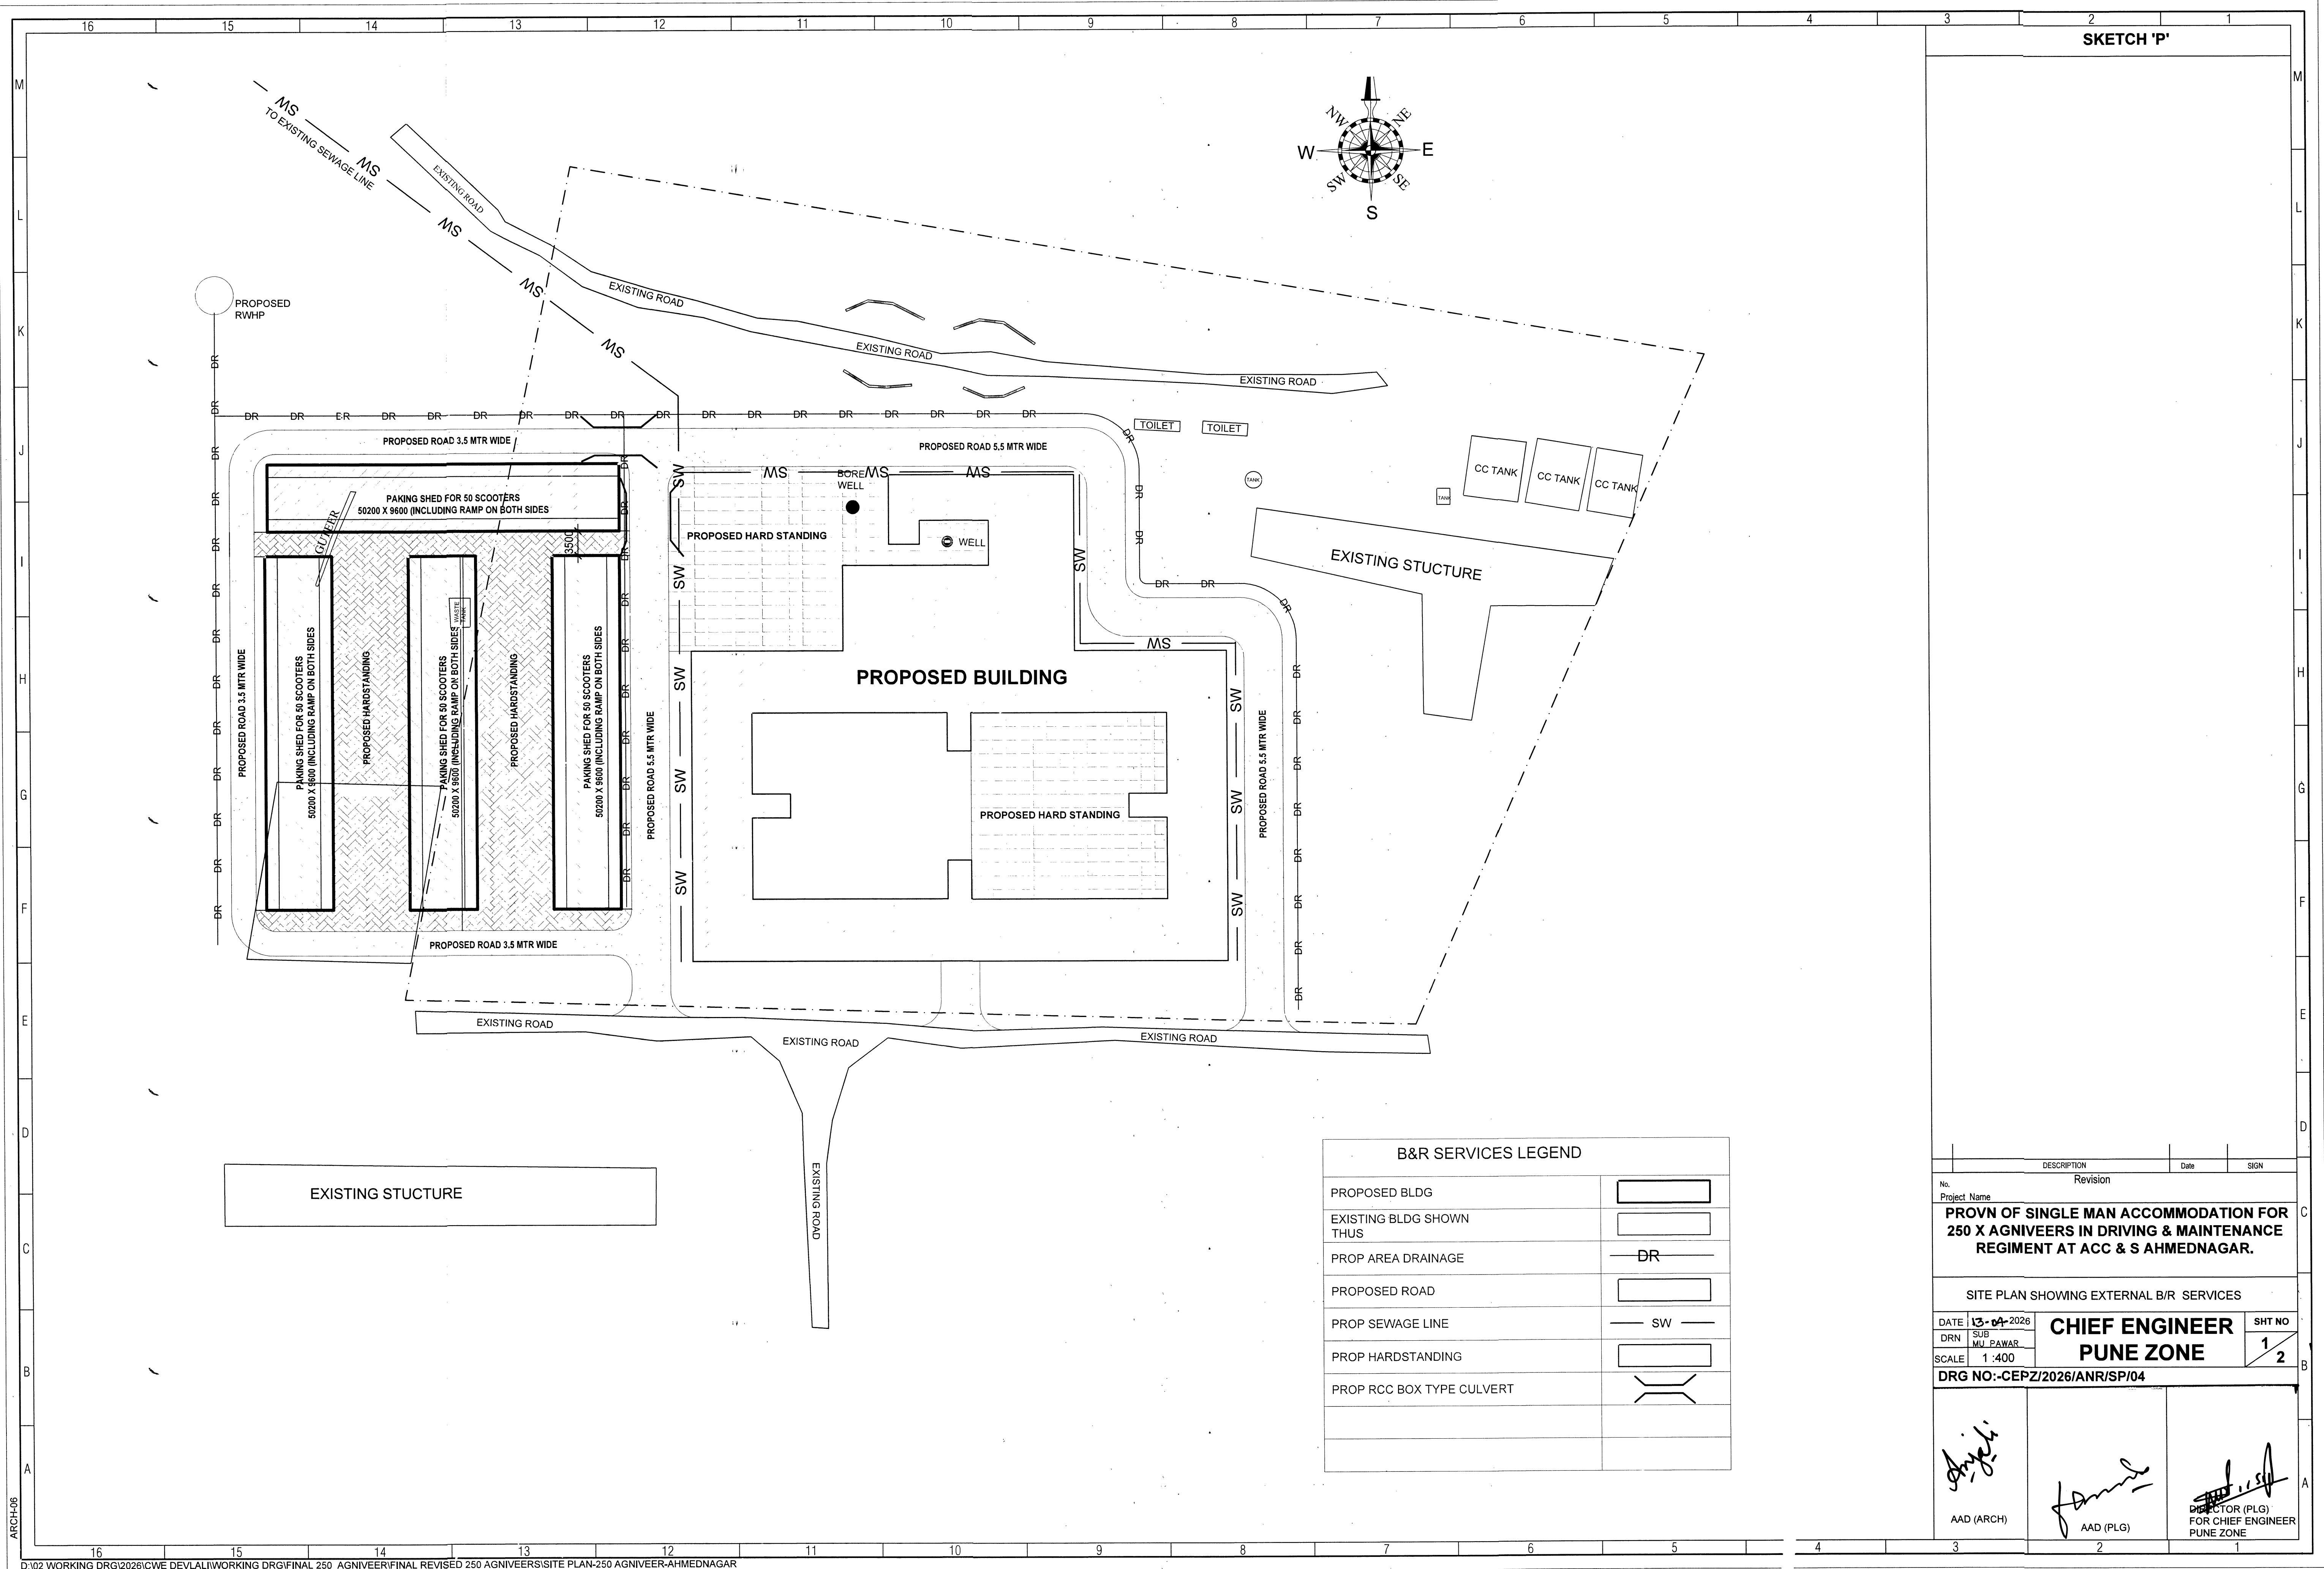

SKETCH 'P'

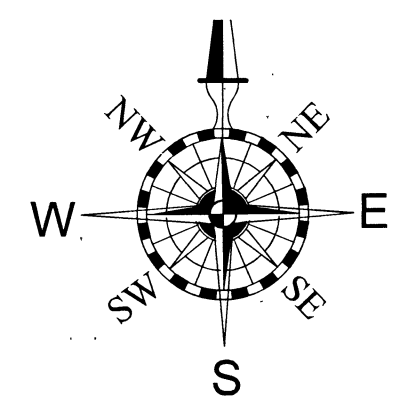

B&R SERVICES LEGEND	
PROPOSED BLDG	[Symbol: Solid rectangle]
EXISTING BLDG SHOWN THUS	[Symbol: Dashed rectangle]
PROP AREA DRAINAGE	[Symbol: Line with 'DR' text]
PROPOSED ROAD	[Symbol: Double line]
PROP SEWAGE LINE	[Symbol: Line with 'SW' text]
PROP HARDSTANDING	[Symbol: Stippled area]
PROP RCC BOX TYPE CULVERT	[Symbol: Two parallel lines with a break symbol]

No.	Description	Date	Sign
Revision			
Project Name			
PROVN OF SINGLE MAN ACCOMMODATION FOR 250 X AGNIVEERS IN DRIVING & MAINTENANCE REGIMENT AT ACC & S AHMEDNAGAR.			
SITE PLAN SHOWING EXTERNAL B/R SERVICES			
DATE: 13-04-2026	CHIEF ENGINEER PUNE ZONE		SHT NO: 1/2
DRN: M/L PAWAR			
SCALE: 1:400			
DRG NO:-CEPZ/2026/ANR/SP/04			
AAD (ARCH)	AAD (PLG)	DIRECTOR (PLG) FOR CHIEF ENGINEER PUNE ZONE	